


SITE PLAN
2020 ANNUAL REPORT
FIGURE 1

Prein&Newhof
079049

LEGEND

- Purge Well
- Monitoring Well (Screen Depth Below Water Table)
- Discharge Piping
- Purge Well Piping

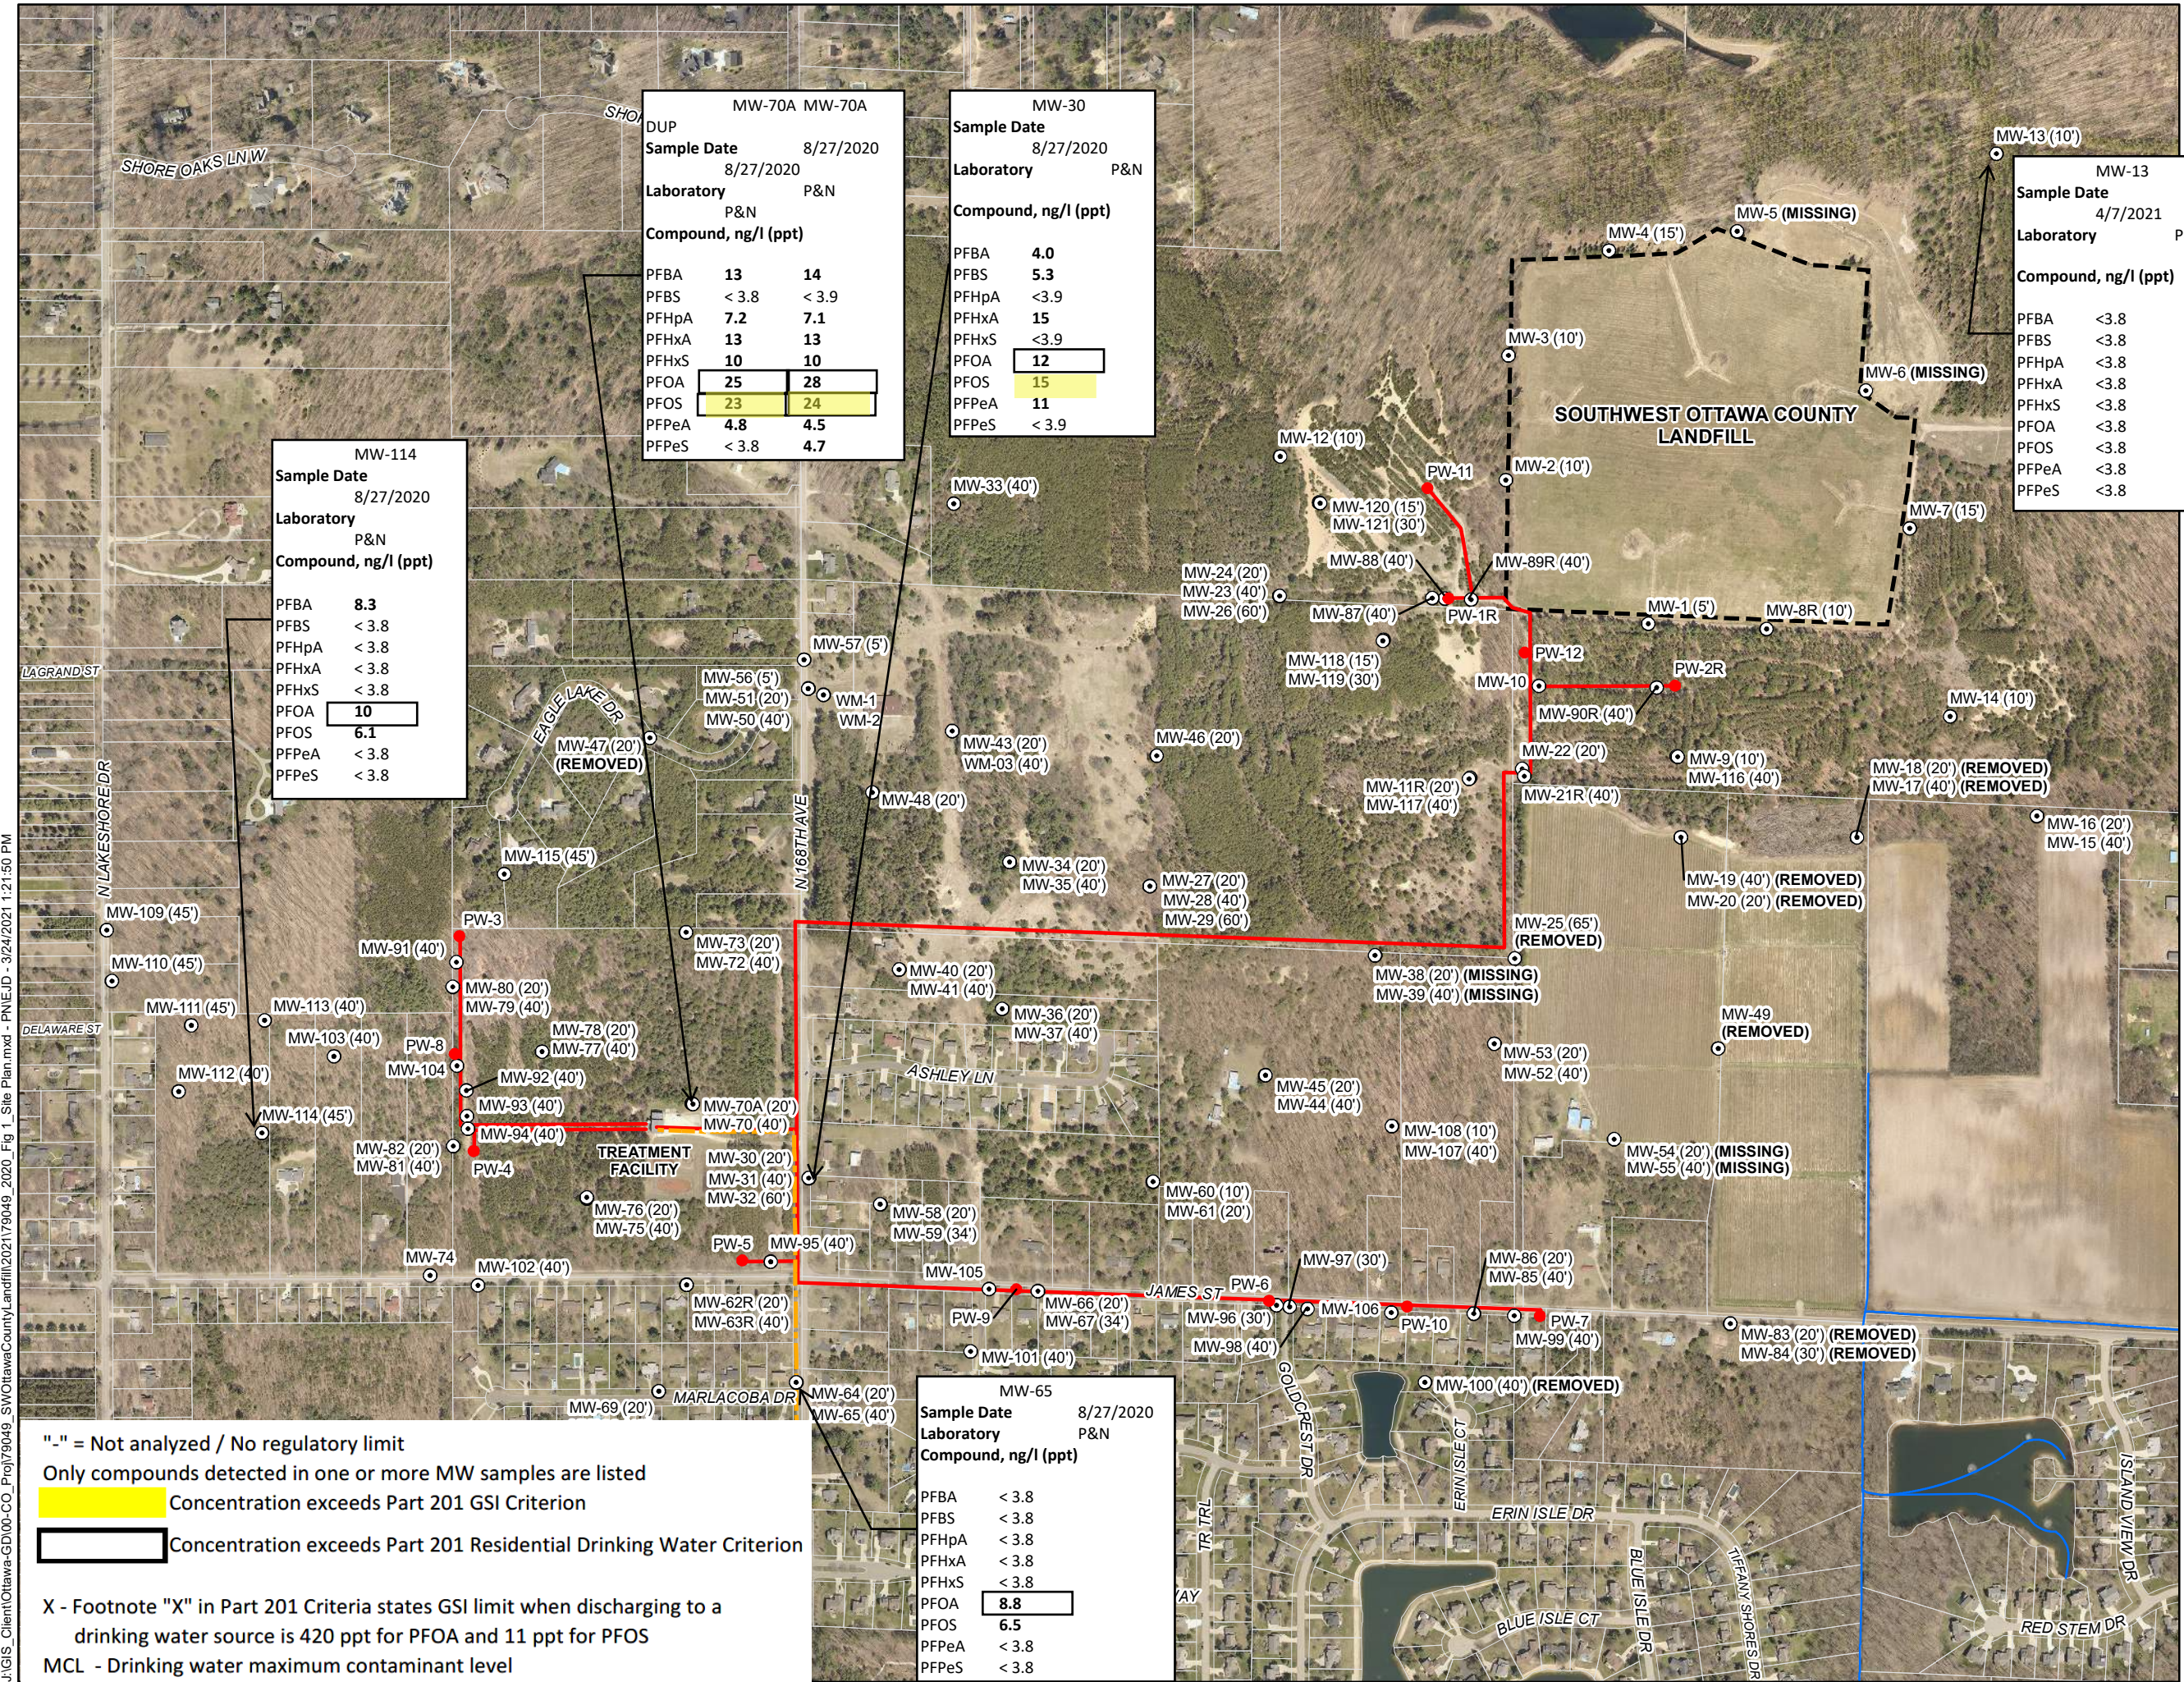

"-" = Not analyzed / No regulatory limit

Only compounds detected in one or more MW samples are listed

Concentration exceeds Part 201 GSI Criterion

Concentration exceeds Part 201 Residential Drinking Water Criterion

X - Footnote "X" in Part 201 Criteria states GSI limit when discharging to a drinking water source is 420 ppt for PFOA and 11 ppt for PFOS

MCL - Drinking water maximum contaminant level



- Groundwater Contour
- Purge Well
- ⊙ Monitoring Well (Screen Depth Below Water Table)
- ⦿ Monitoring Well With Static Water Elevation
- - - Discharge Piping

1. At locations where multiple wells screened at different depths were sampled, the contours were generated by using the highest observed elevation in the group.
2. Purge well water levels are shown but not included in static water level contours.



SCALE: 1" = 600'